
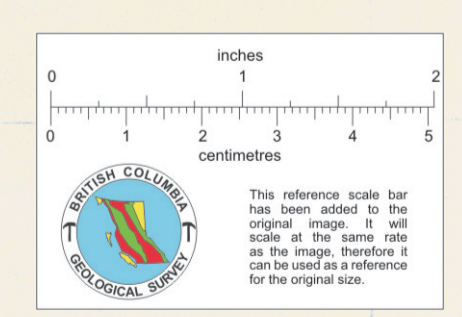


37-5670

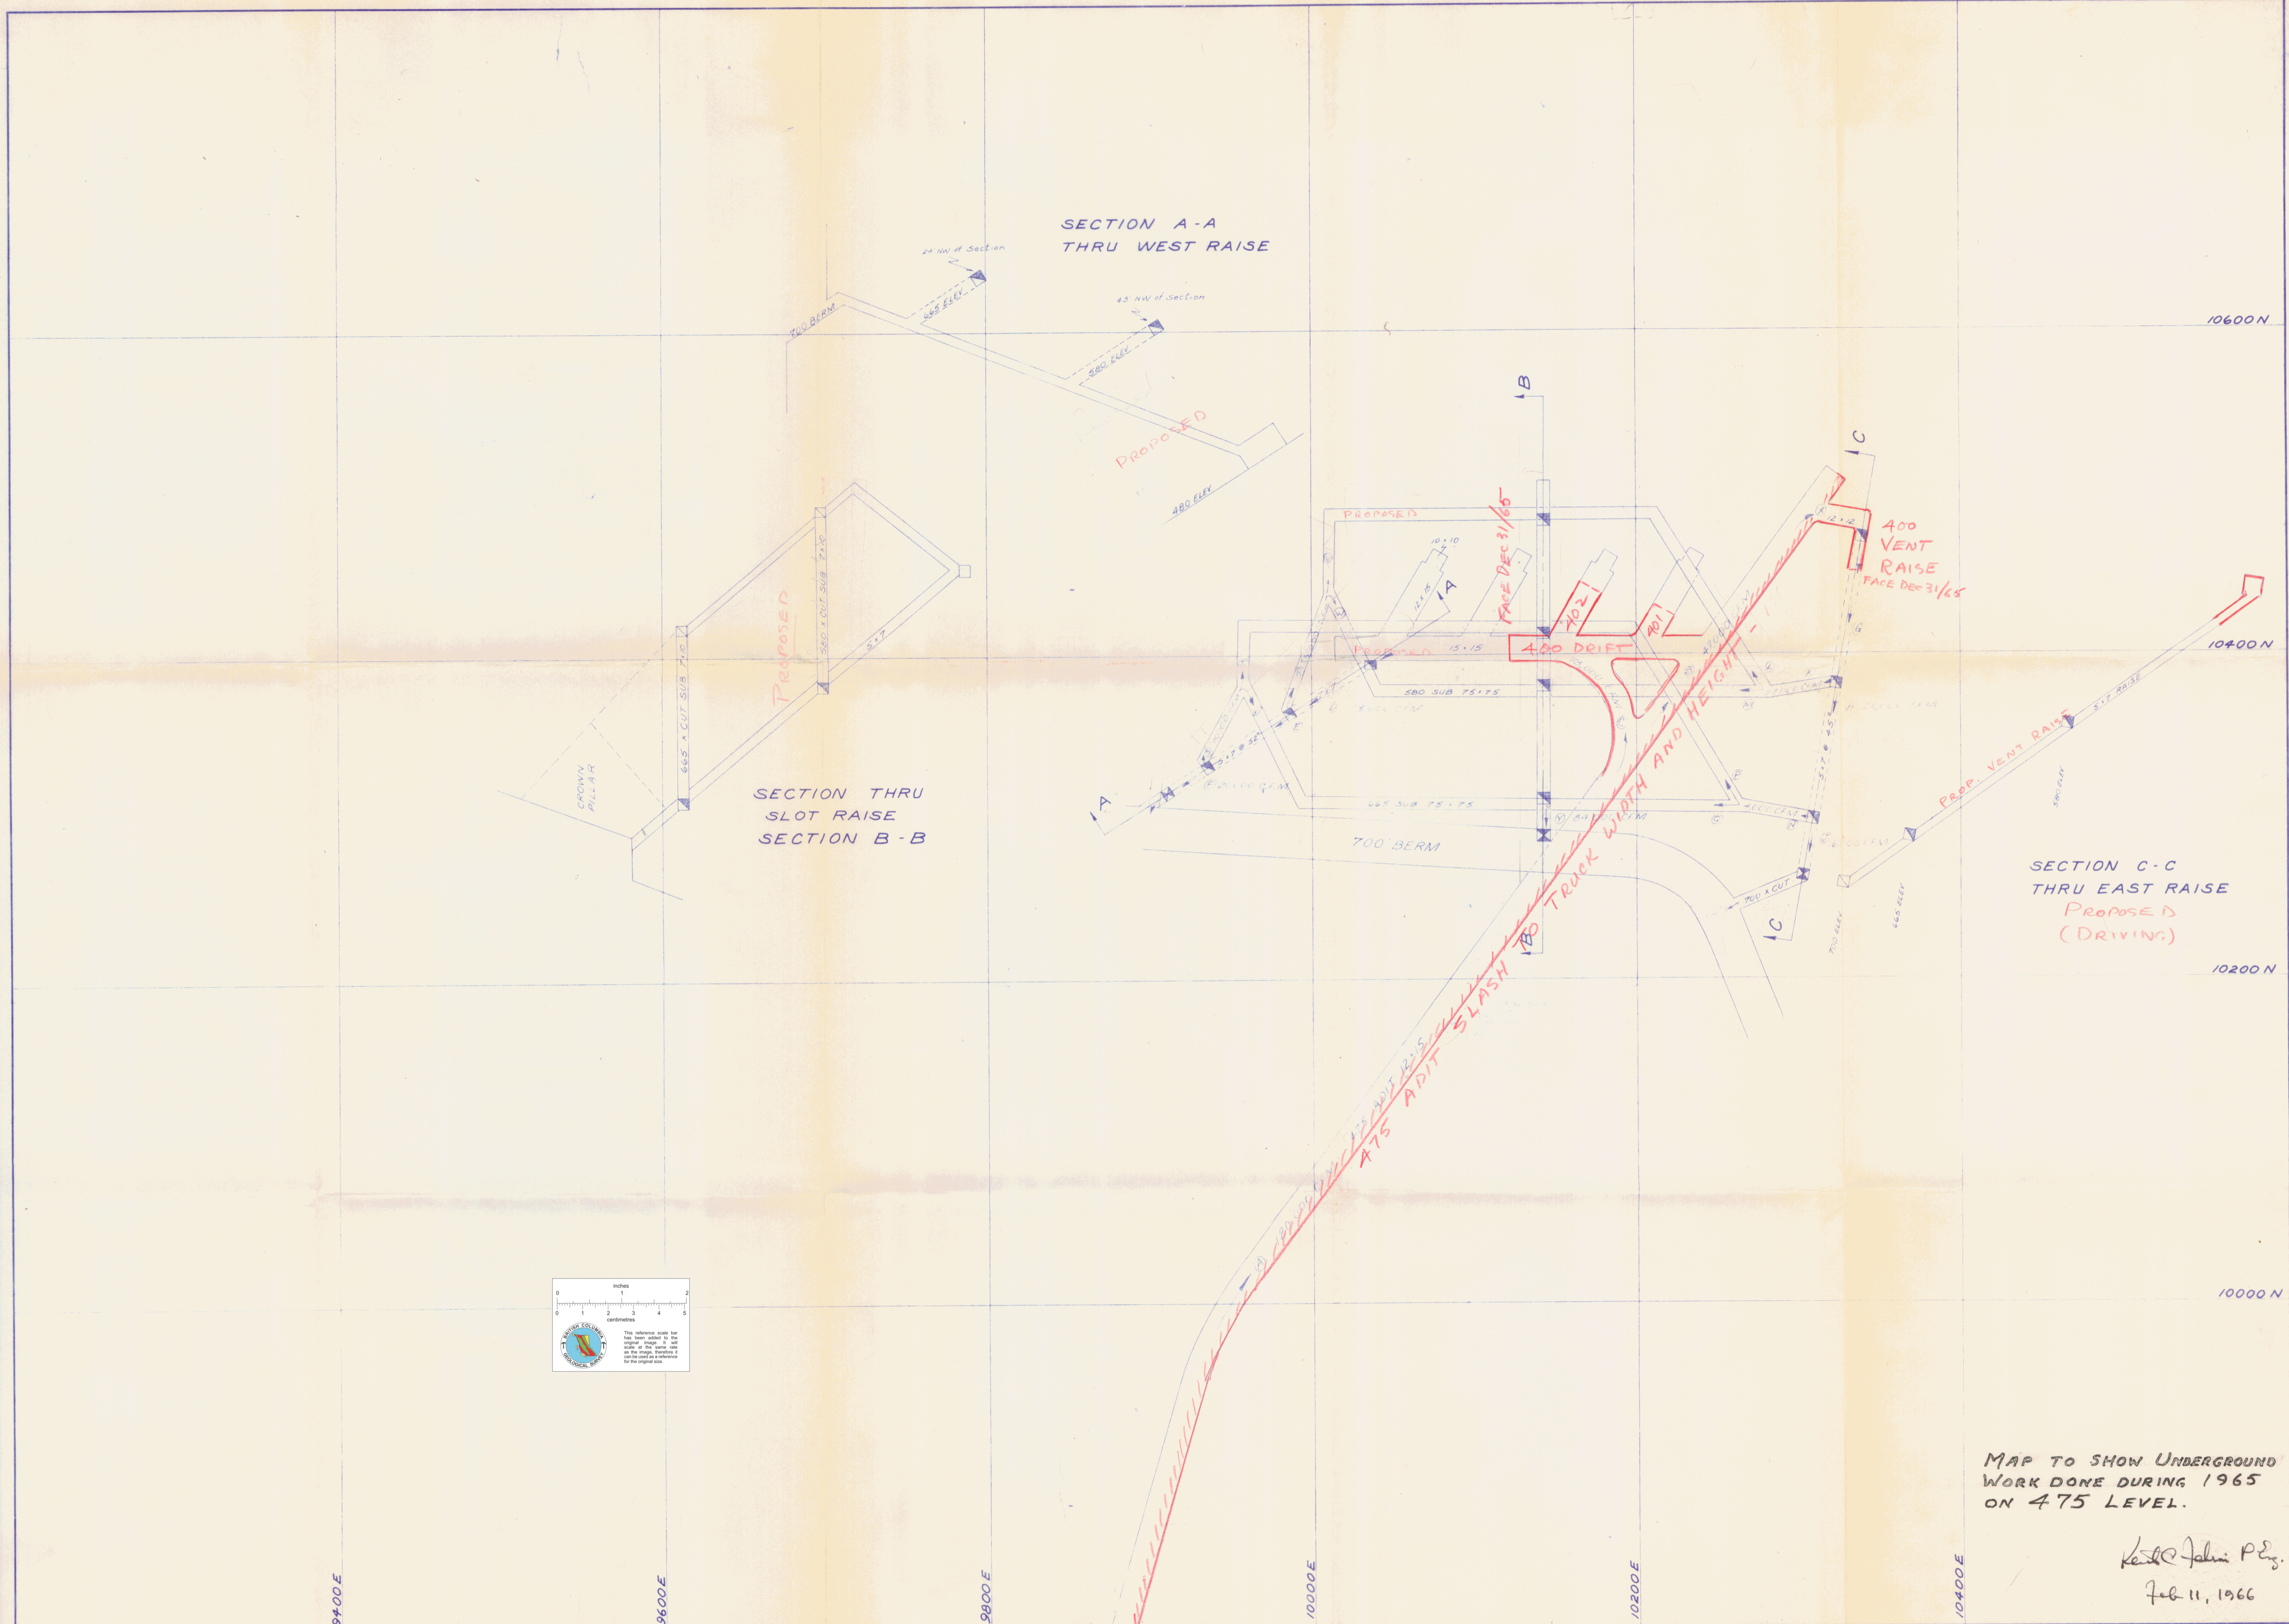

MAP TO SHOW UNDERGROUND
WORK DONE DURING 1965
ON 475 LEVEL.

Kent John P. Eng.
Feb. 11, 1966

DATE	REVISIONS	BY	DRAWN	CHECKED	APPROVED	DATE

JEDWAY IRON ORE LIMITED

Scale: 1 inch = 40 Feet

TITLE UNDERGROUND VENTILATION PLAN
PLAN No. 1a
Schd. # 1

017194